



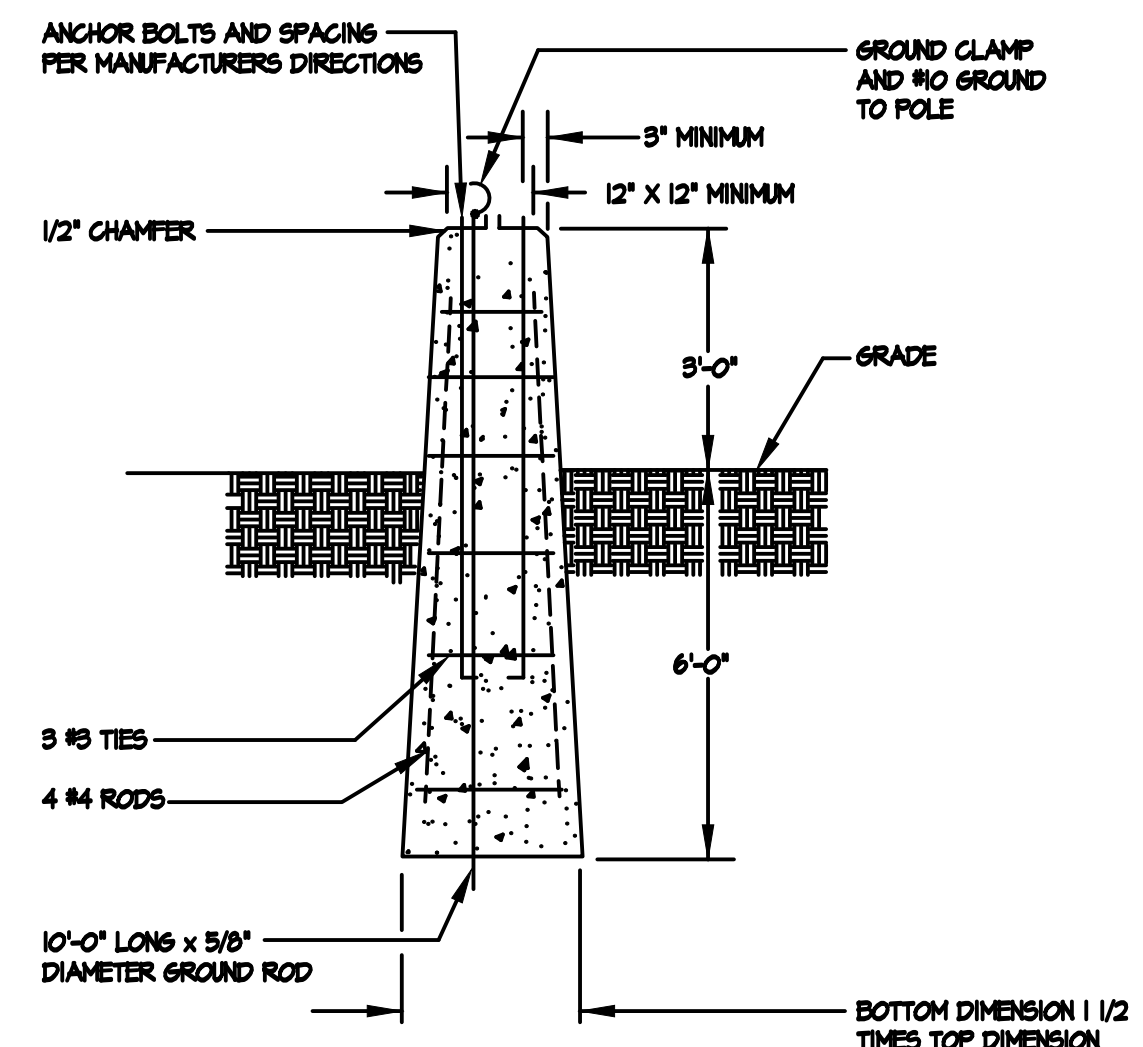

CITY OF EAST PROVIDENCE
POTTER STREET AND BURGESS STREET PARKING LOTS
ADDENDUM # 1
RFP EP22/23-29
BID OPENING FRIDAY SEPTEMBER 8, 2023 AT 11:00AM

LIST OF PLAN CHANGES:

- Add Sheet 12 of 12 – Electrical Site Plan to the Volume 1 Potter Street at Warren Avenue Plans.

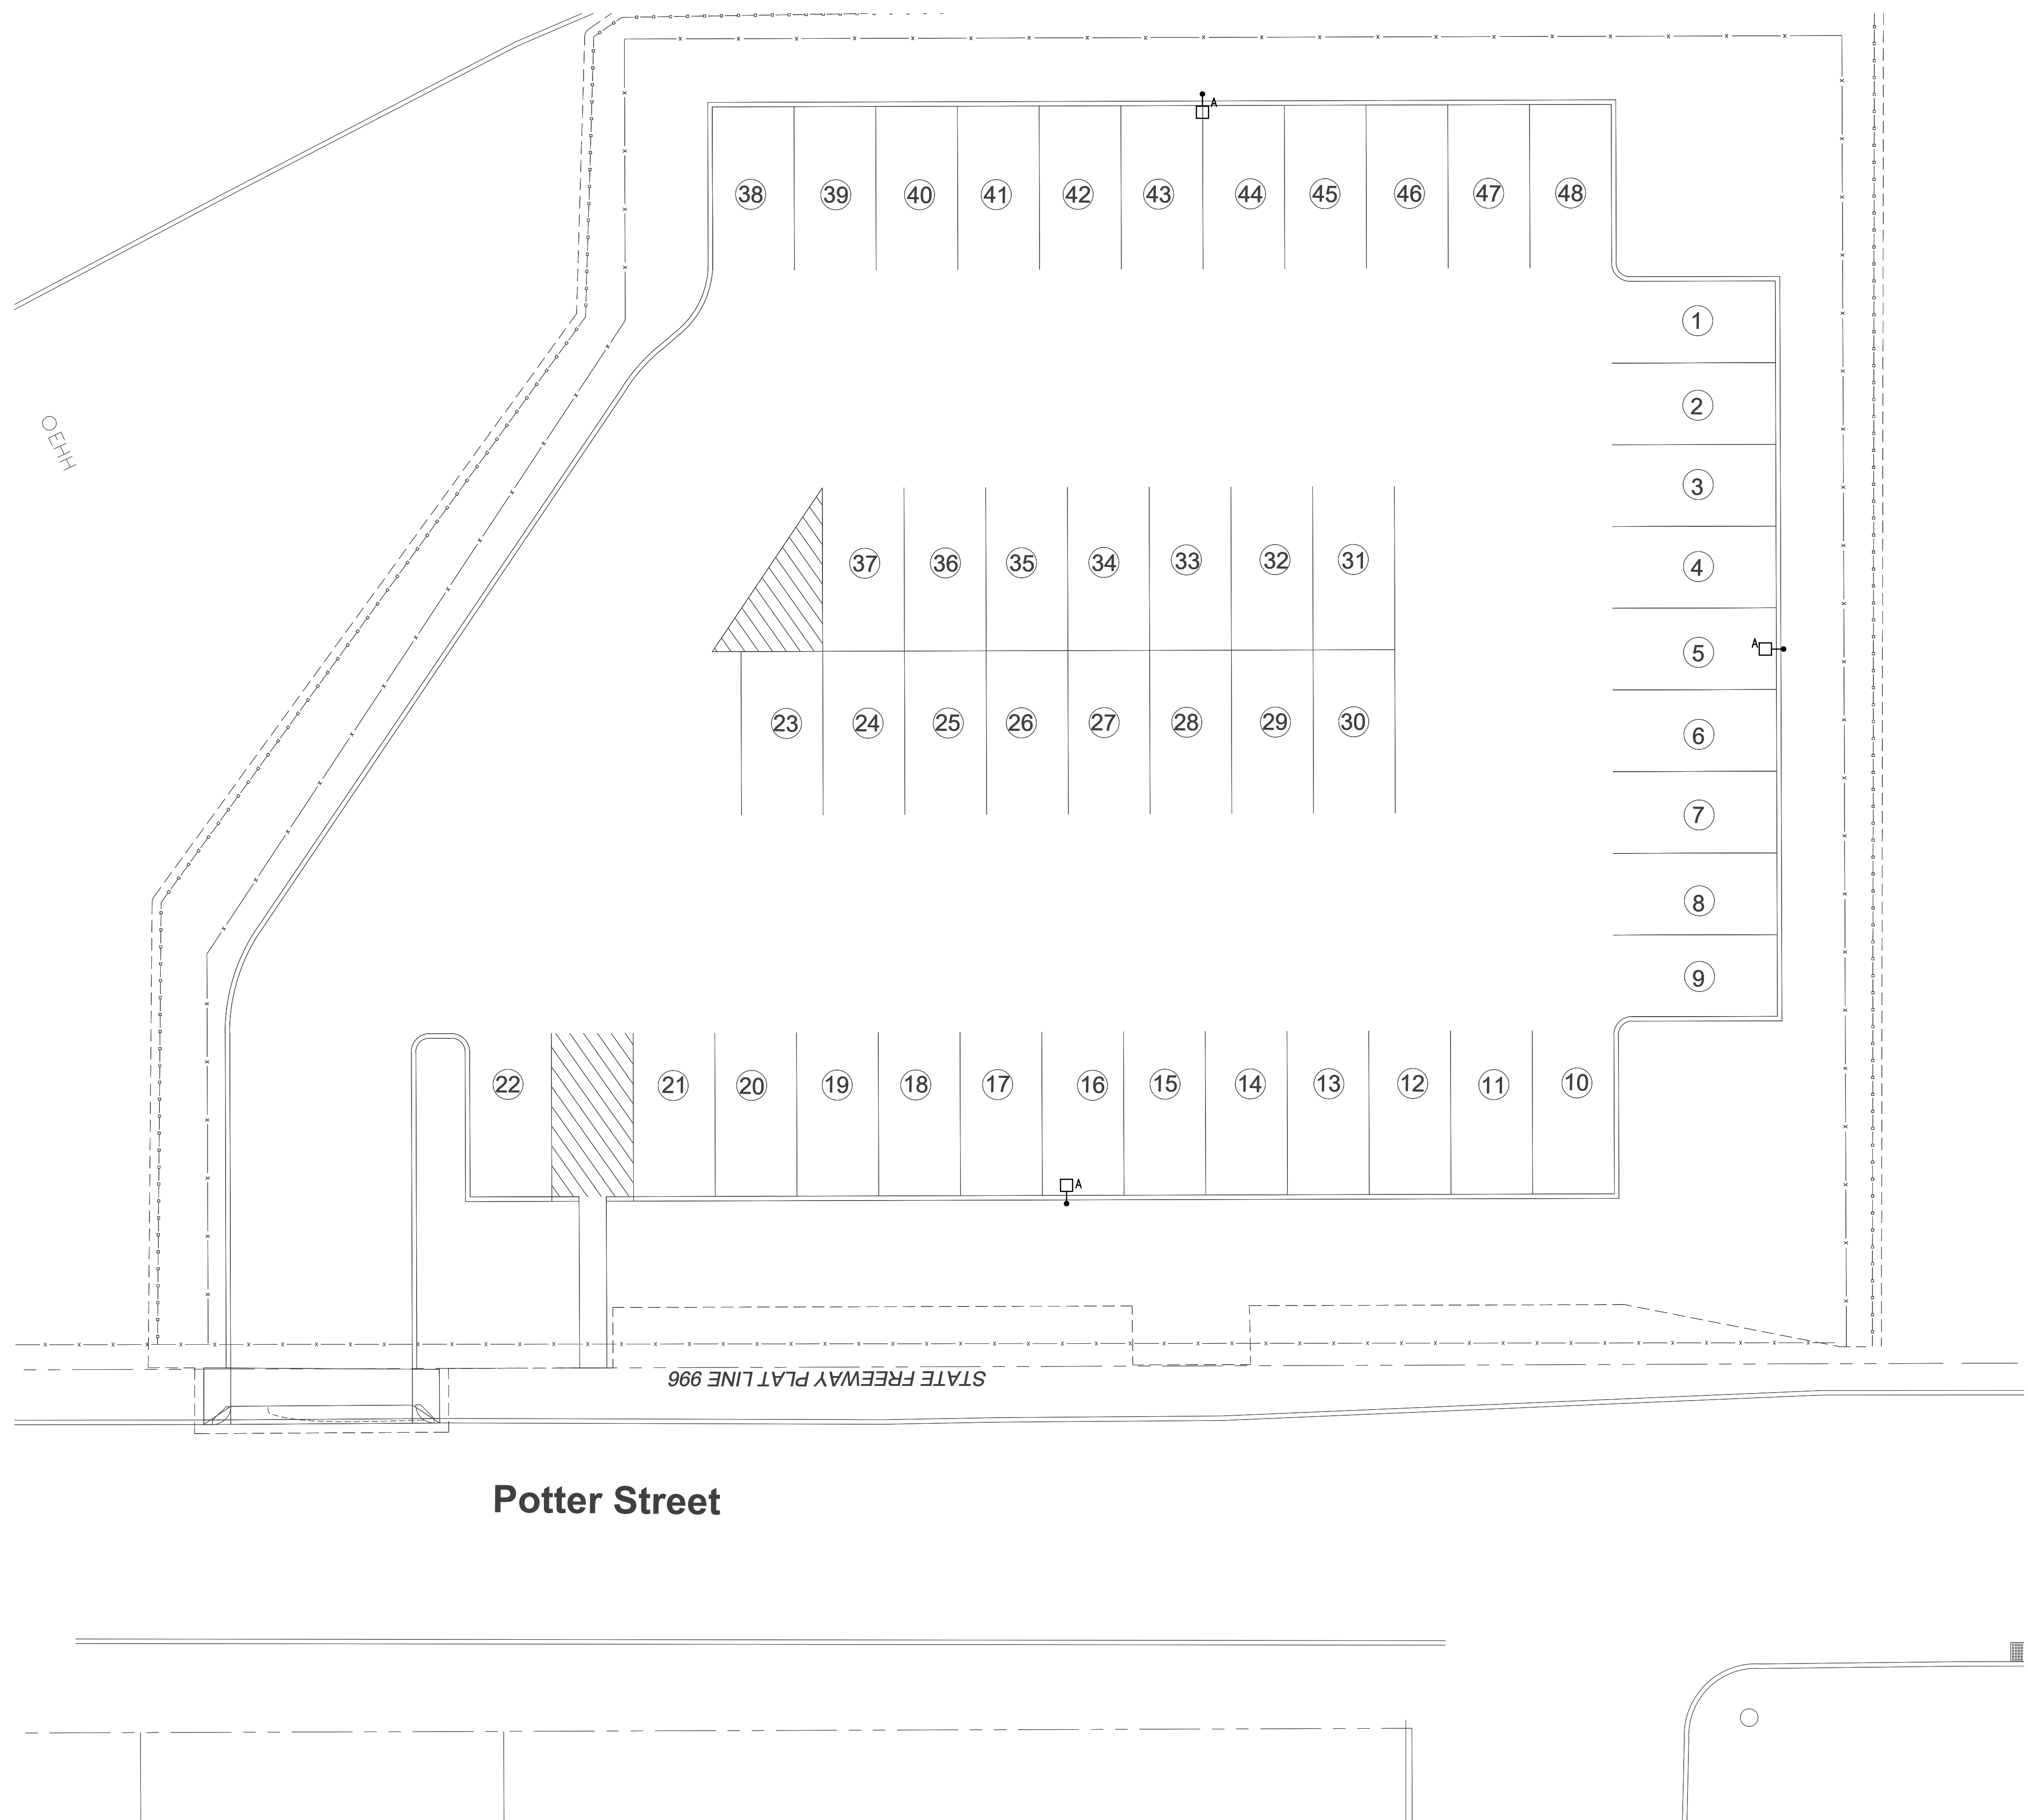

POLE BASE DETAIL
NOT TO SCALE

ELECTRICAL SYMBOL LEGEND

☐ SOLAR OPERATED POLE LIGHT

ABBREVIATIONS
GRD GROUND

LIGHTING FIXTURE SCHEDULE					
TYPE	DESCRIPTION	MANUFACTURER & CATALOG NUMBER	LAMPS		INPUT WATTS
			NUMBER	TYPE	
A	<ul style="list-style-type: none"> 24.5 FOOT BLACK STEEL POLE INCLUDING BASE BATTERY CABINET SIGMA SERIES ESLD-60-62W LIGHT FIXTURE ON A 6' LIGHT ARM BOSH MOTION SENSOR DUAL 315 WATT 60 CELL SOLAR PANEL DUAL 145AH AGM, THICK PLATE, LONG LIFE, DEEP CYCLE LEAD ACID BATTERIES PREPACKAGED CABLING HARNESS KIT FOR A QUICK EASY INSTALLATION CLEAR BLUE TECHNOLOGIES SMART OFF GRID CONTROLLER INCLUDE 3 YEARS OF ILLUMINANCE SMART OFF-GRID CLOUD-BASED MONITORING AND CONTROL INCLUDE 3 YEARS OF COMMUNICATIONS, CELLULAR FOR SINGLE UNITS AND MESH/ETHERNET OR MESH/CELLULAR FOR MULTI-POLE PROJECTS 	CLEAR BLUE TECHNOLOGIES ILLUMINANCE STRADA DUAL SOLAR SMART OFF GRID LIGHTING #CBT-DS1L-MS24.5	1	LED	62
				12	

FILE: P:\2022-ALL PROJECTS\22089-POTTER STREET - E. PROJ. RI\DRAWINGS\ELEC\22089-E.DWG PLOT DATE: 7/26/2023 11:41 AM



RHODE ISLAND
DEPARTMENT OF TRANSPORTATION



DESIGNED BY: WMS
CHECKED BY: WMS
DATE: 6/6/23
SHEET: 12
OF: 12

SCALE: 1" = 20'

REVISIONS			REVISIONS		
NO.	DATE	BY	NO.	DATE	BY

**POTTER STREET AT
WARREN AVENUE PARKING LOT**
EAST PROVIDENCE
RHODE ISLAND
ELECTRICAL SITE PLAN