


GENERAL NOTES
1. ALL CONTRACTORS SHALL CONFIRM CLEARANCES
NEEDED TO INSTALL THEIR WORK PRIOR TO
PROCEEDING. CONTACT ARCHITECT FOR DISCREPANCY
RESOLUTION.




LEGEND

- 1x4 surface mount fluorescent luminaire: "E" - existing: "R" - remove
- Wall mounted luminaire: "E" - existing: "R" - remove
- Wall mounted incandescent luminaire/sconce: "E" - existing: "R" - remove
- Ceiling mounted luminaire/chandelier: "E" - existing: "R" - remove
- Wall mounted sconce w/ internal switch: "E" - existing: "R" - remove
- Recessed incandescent light fixture: "E" - existing: "R" - remove
- Four foot fluorescent strip luminaire
- 2x2 LED, surface mounted, flat panel luminaire
- 2x4 LED, surface mounted, flat panel luminaire
- Exit signs, internally lit with two emergency light heads
- Exit signs, internally lit with two emergency light heads and remote head capability
- Single pole wall switch: "E" - existing: "R" - remove
- Three-way wall switch: "E" - existing: "R" - remove
- Single pole dimmer switch: "E" - existing: "R" - remove
- Existing wall mounted timer switch
- 20 amp, 120 volt, duplex receptacle: "E" - existing: "R" - remove
- 20 amp, 120 volt, double duplex receptacle: "E" - existing: "R" - remove
- 20 amp, 120 volt, duplex receptacle: "GF" ground-fault protected: "X" - mounted 42" AFF
- 20 amp, 120 volt dishwasher receptacle mounted under sink cabinet and GFCI protected

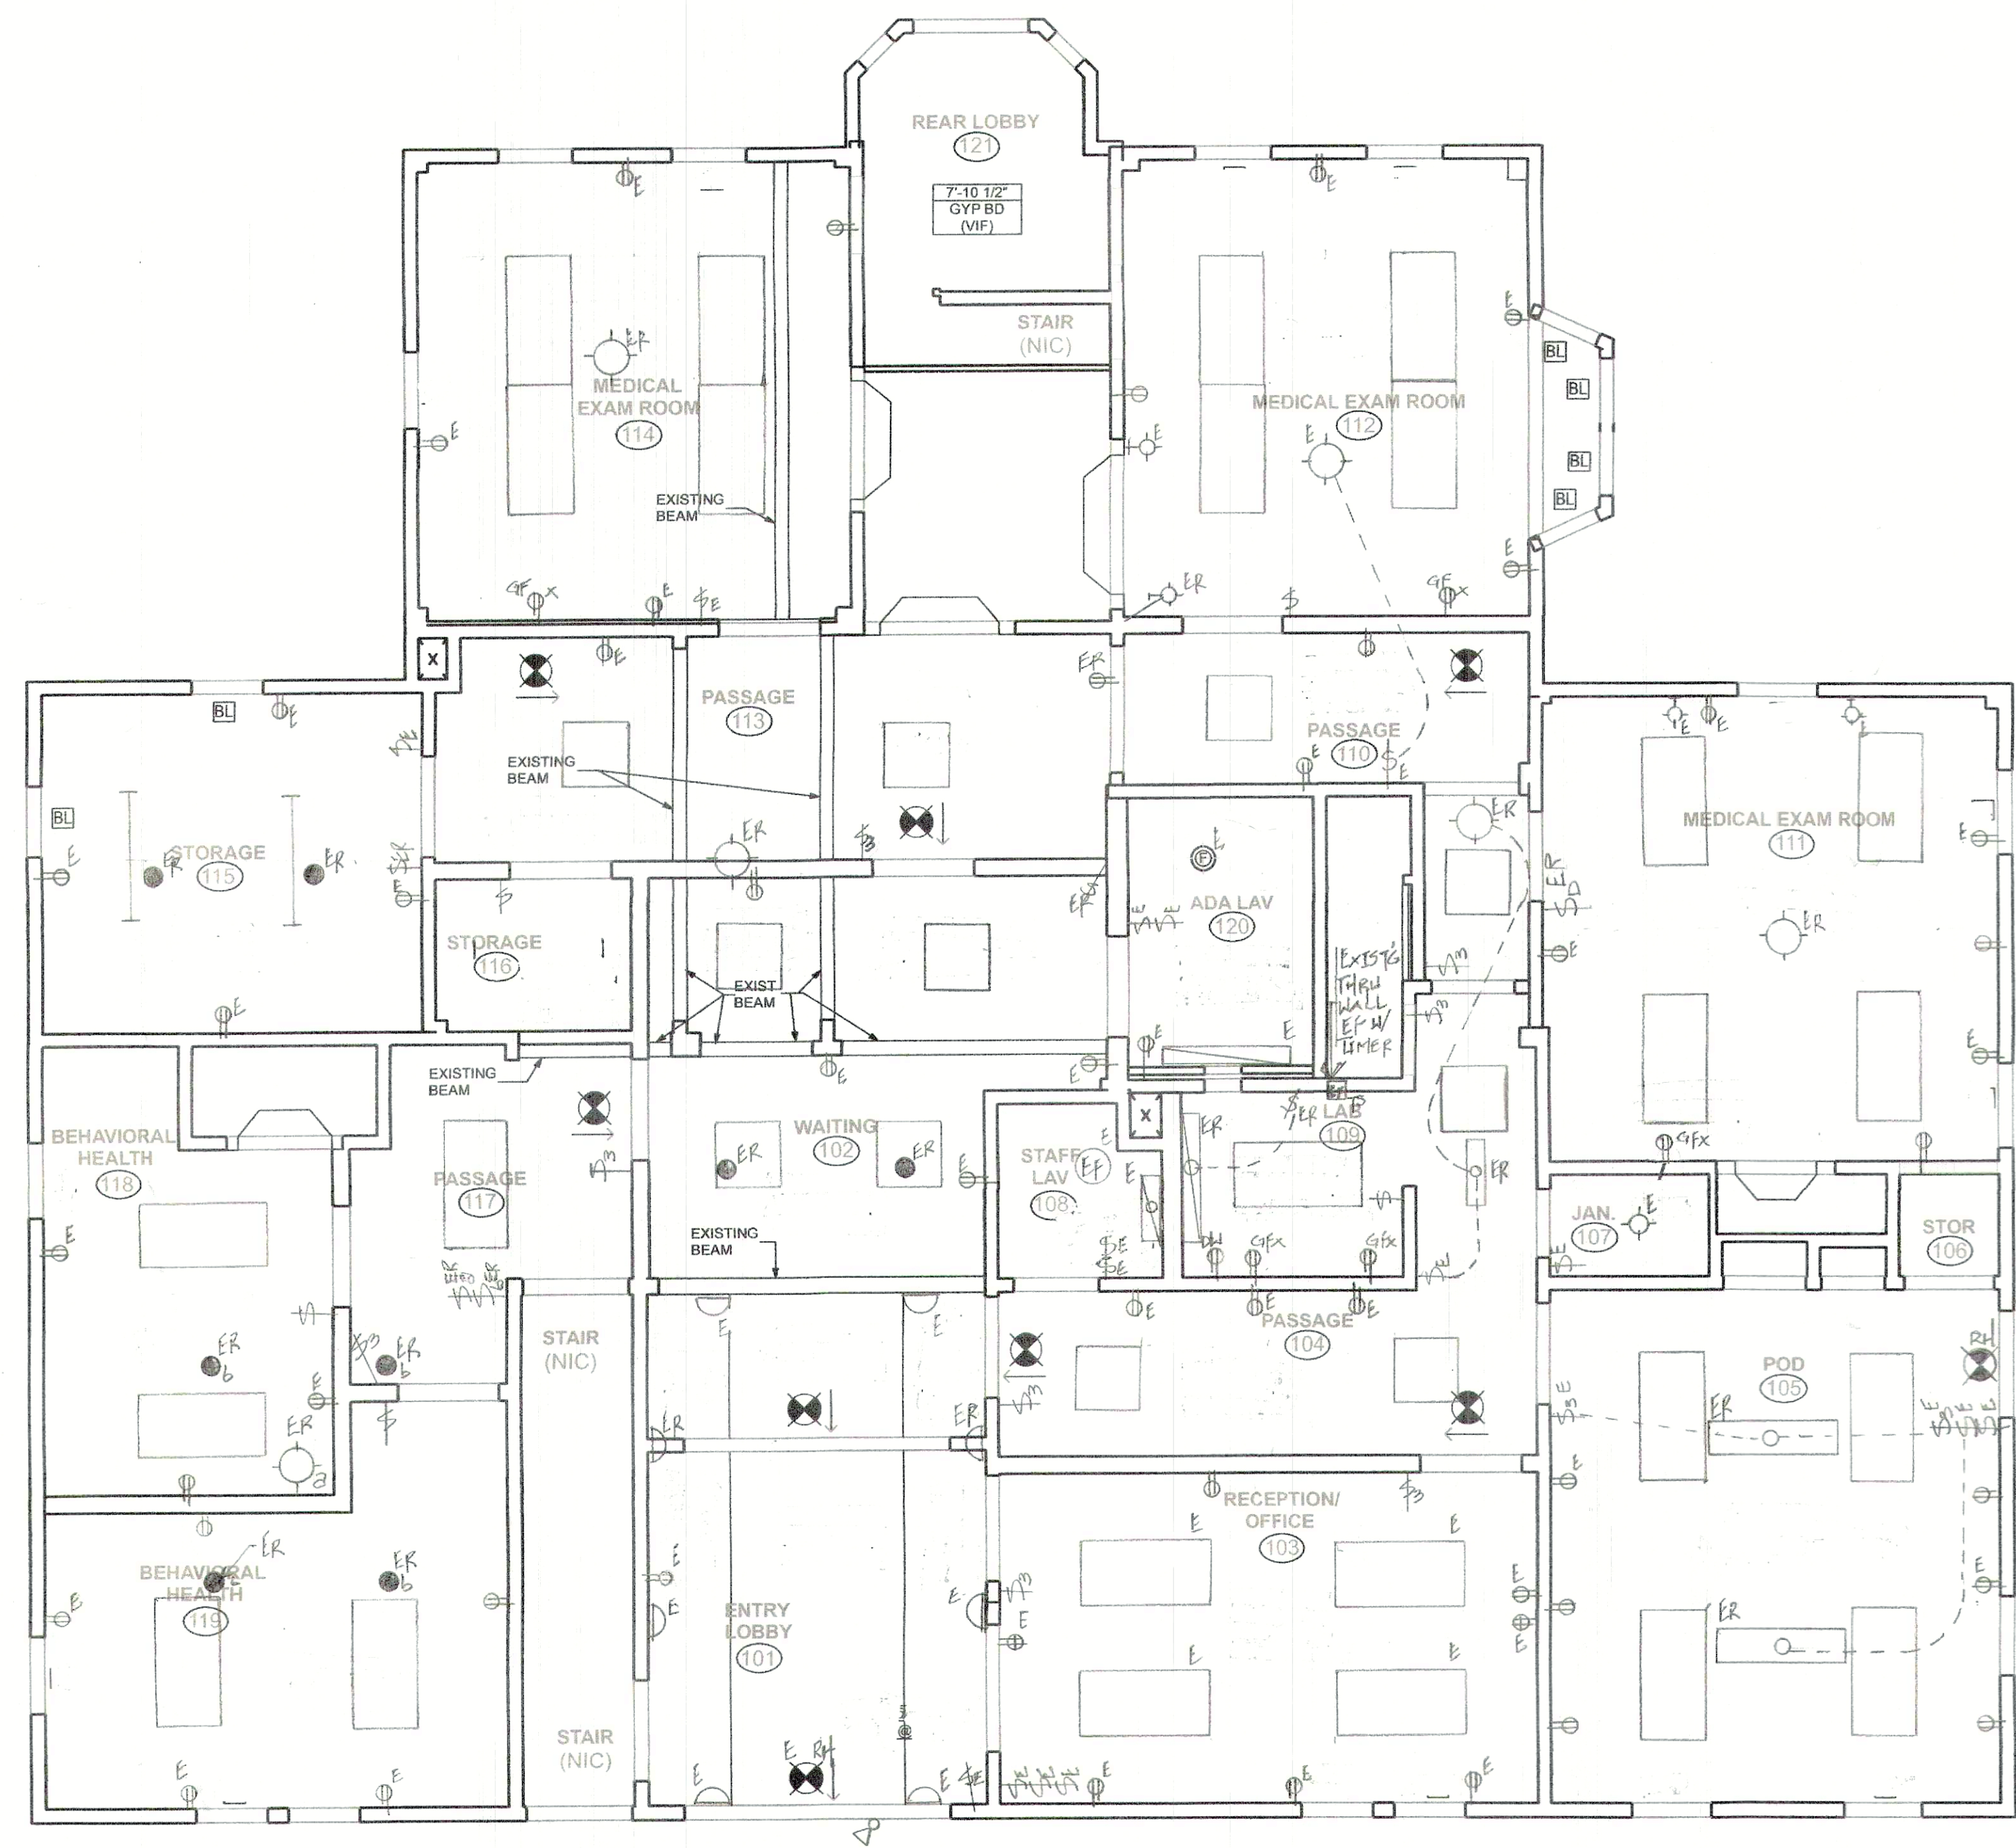


A1
A-112 1st FLOOR REFLECTED CEILING PLAN
SCALE: 1/4" = 1'-0"

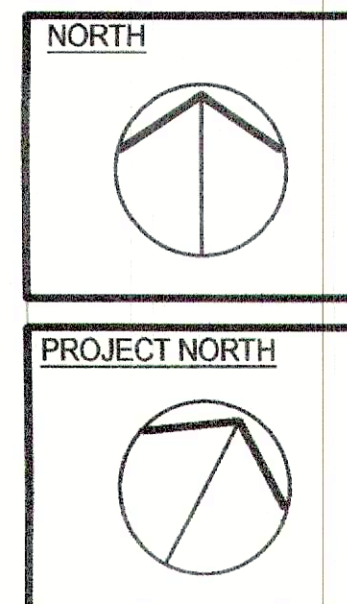

EBCAP - SWEETLAND HOUSE
610 Waterman Street
East Providence, RI. 02914

REVISIONS:

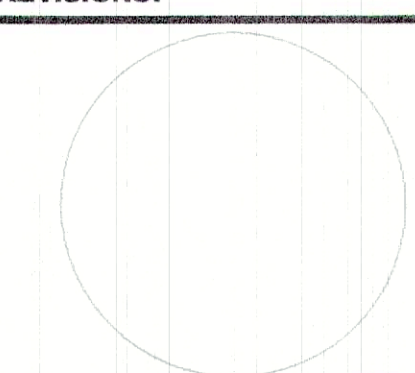

1st FLOOR
REFLECTED
CEILING PLAN


DATE: 10-06-21

NCA JOB NO.: 21111


DRAWING NO.:

A-112


© 2019 NORTHEAST COLLABORATIVE ARCHITECTS

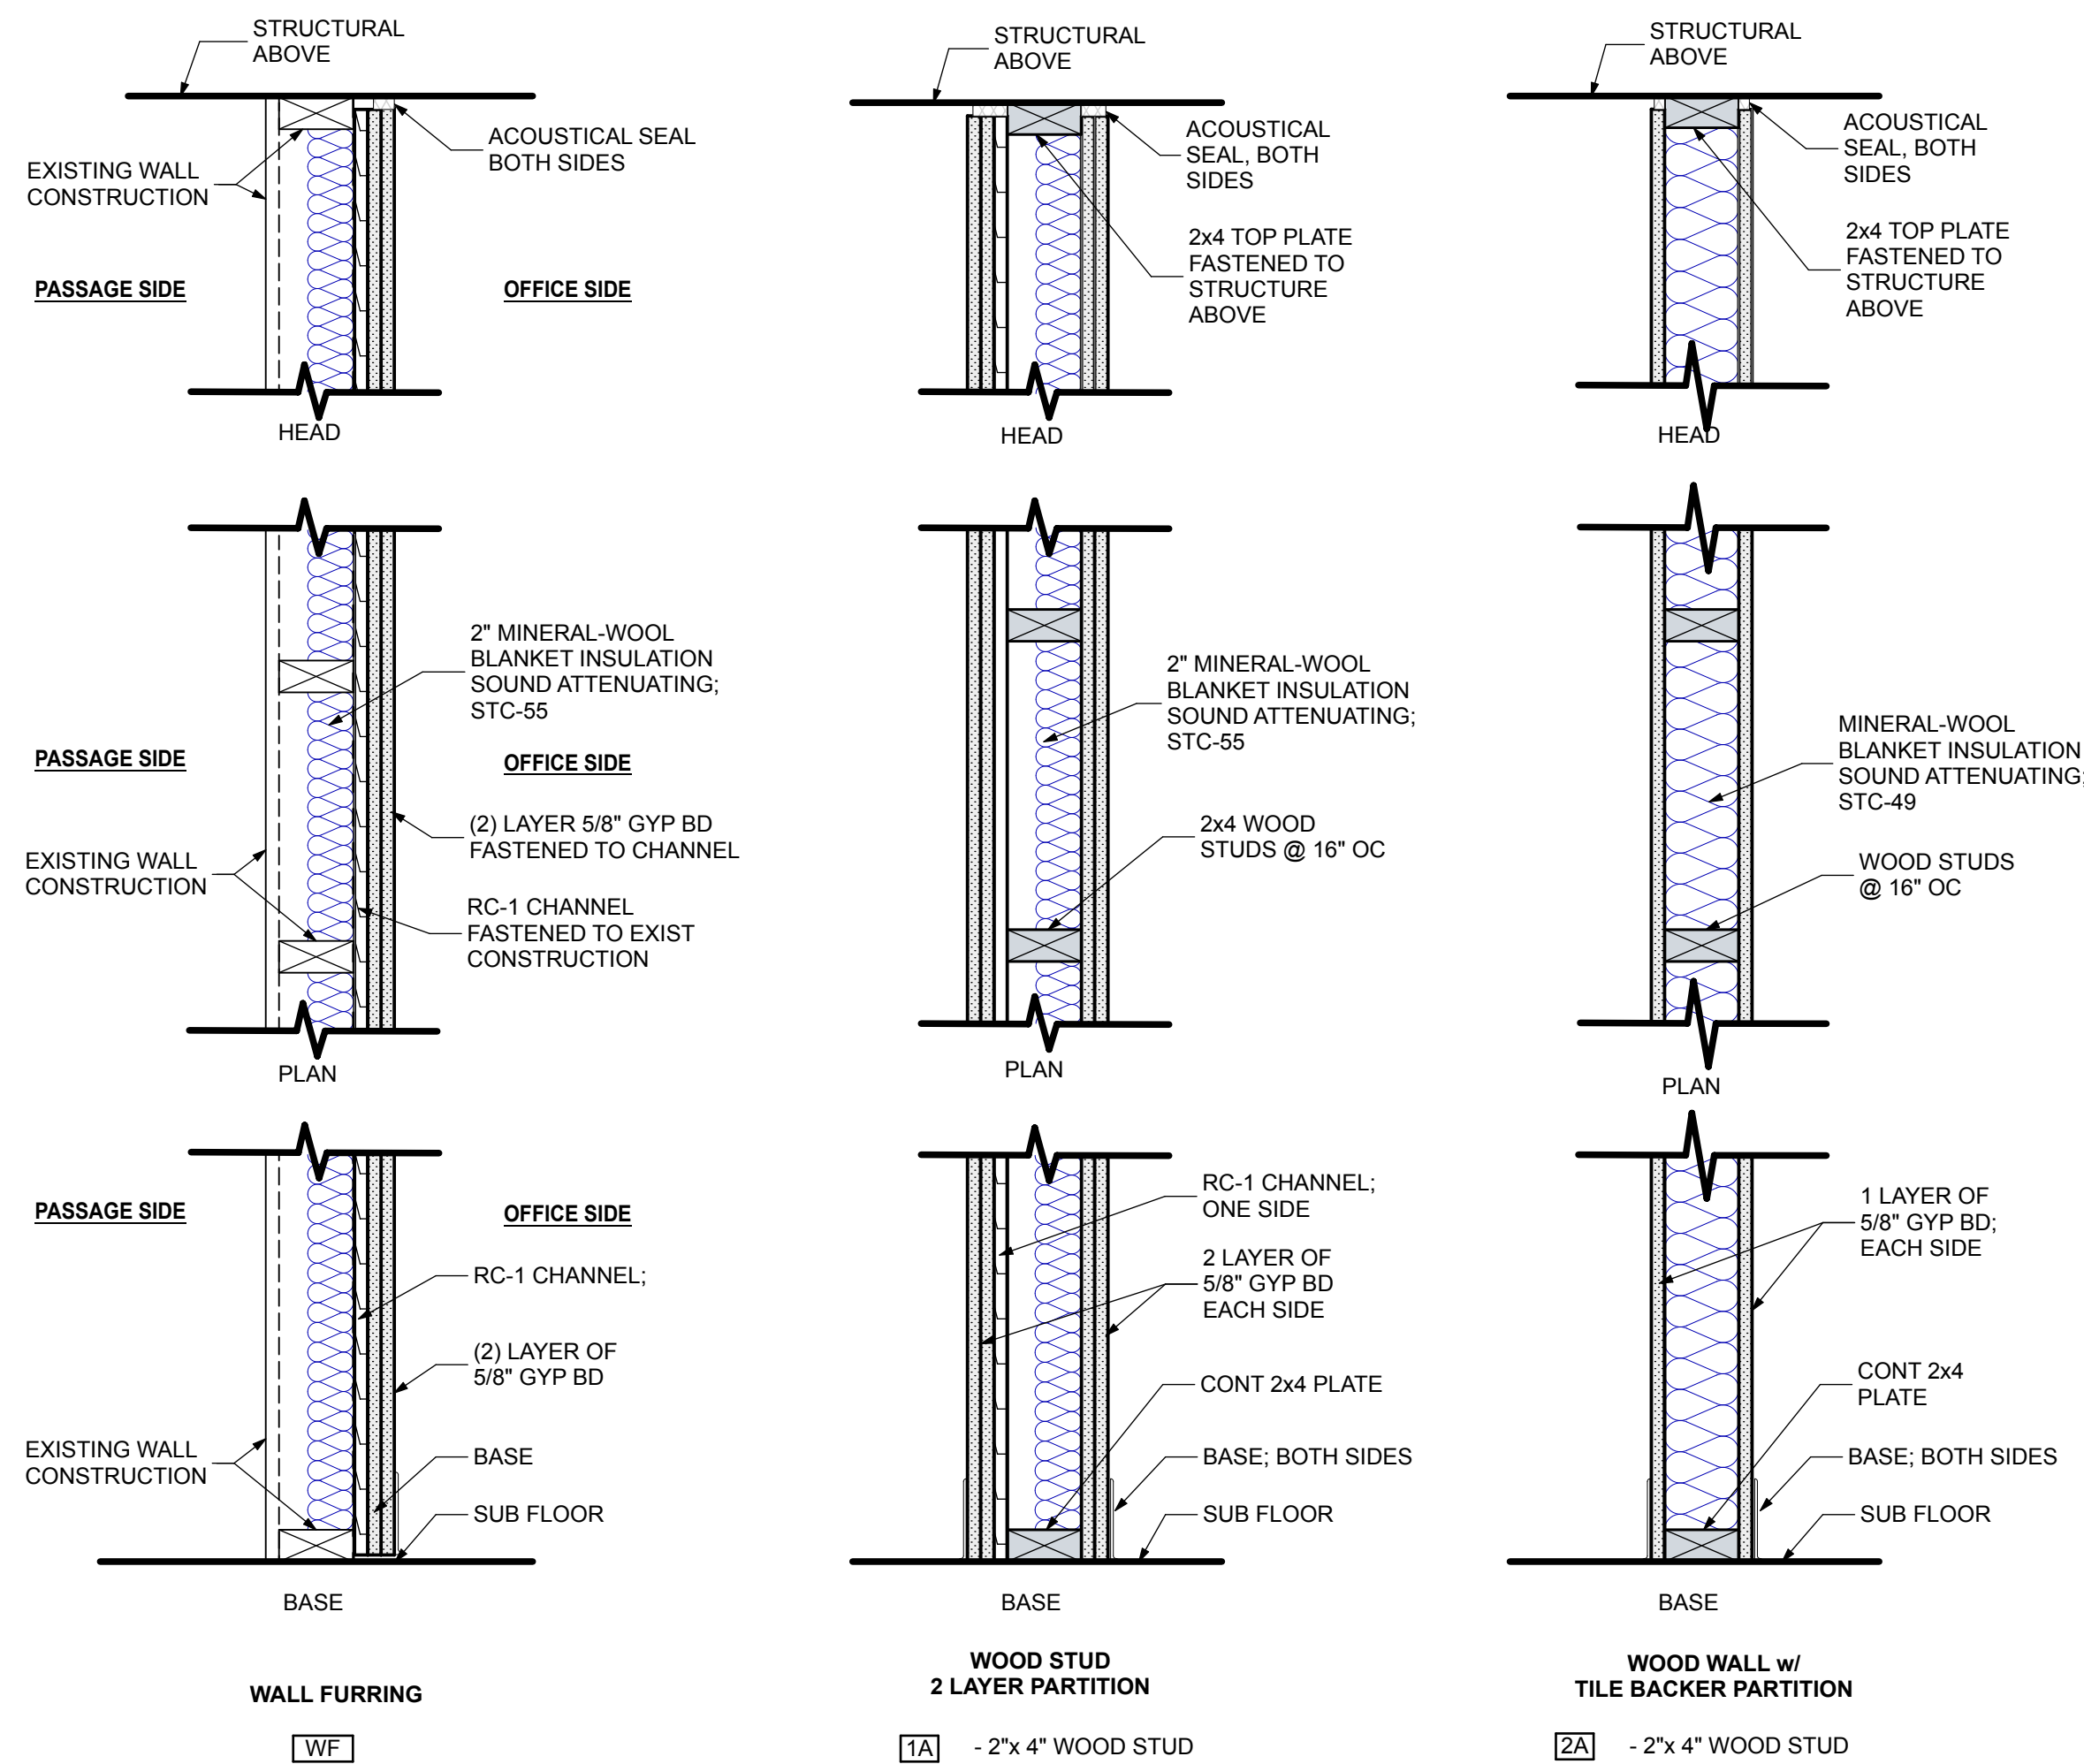


C1 A-113 TYP WALL TYPES SCALE: 1 1/2" = 1'-0"

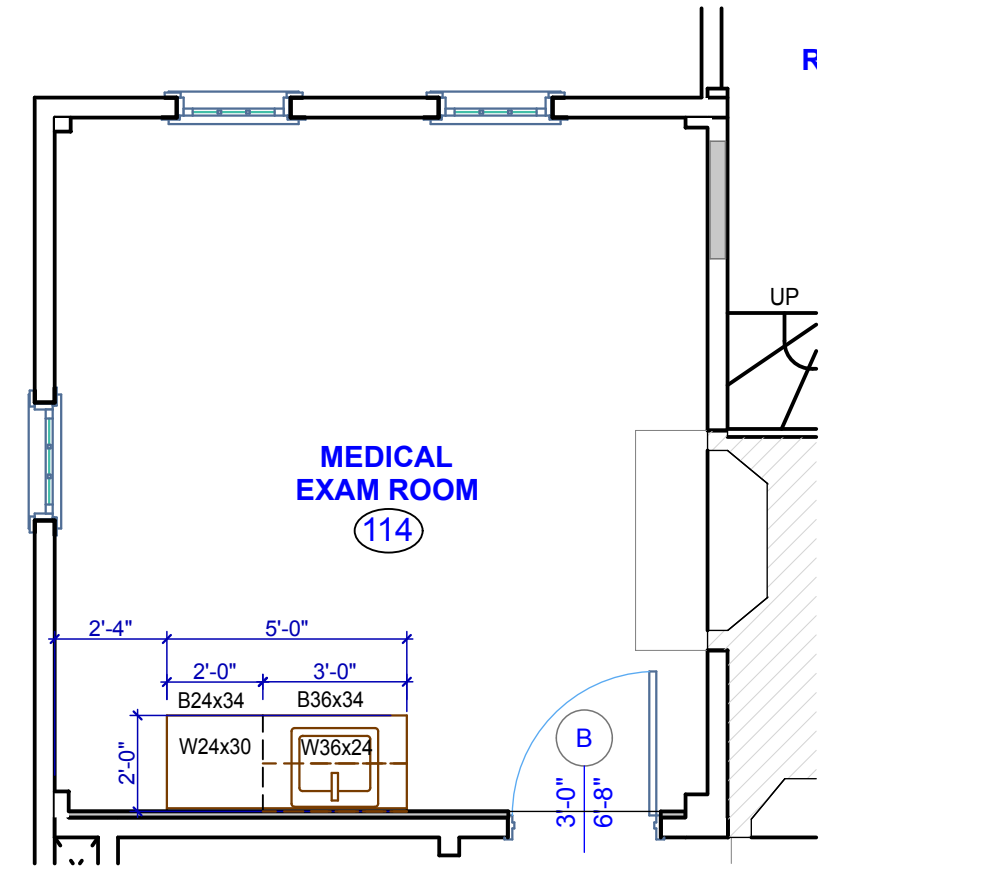


D4 A-113 PARTIAL ENLARGED PLAN SCALE: 1/4" = 1'-0"

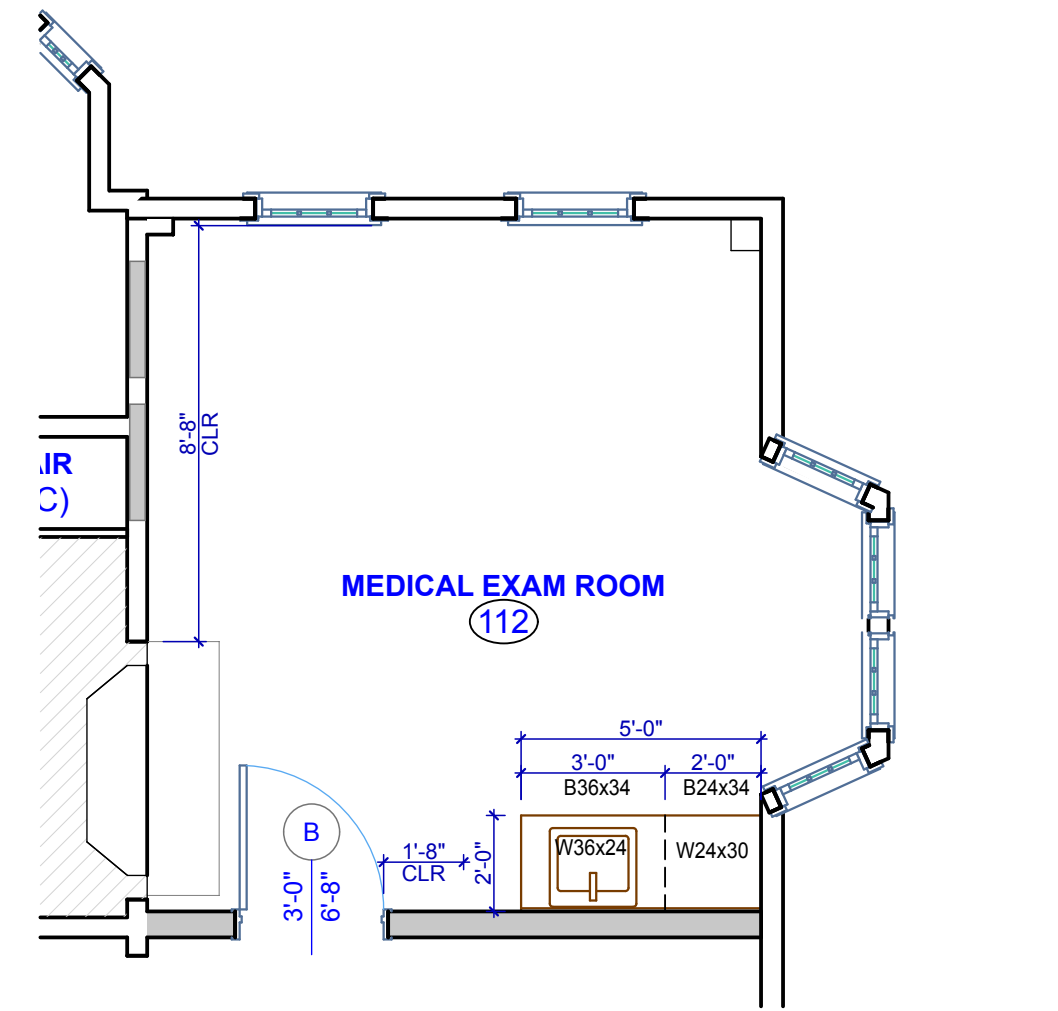


D5 A-113 PARTIAL ENLARGED PLAN SCALE: 1/4" = 1'-0"

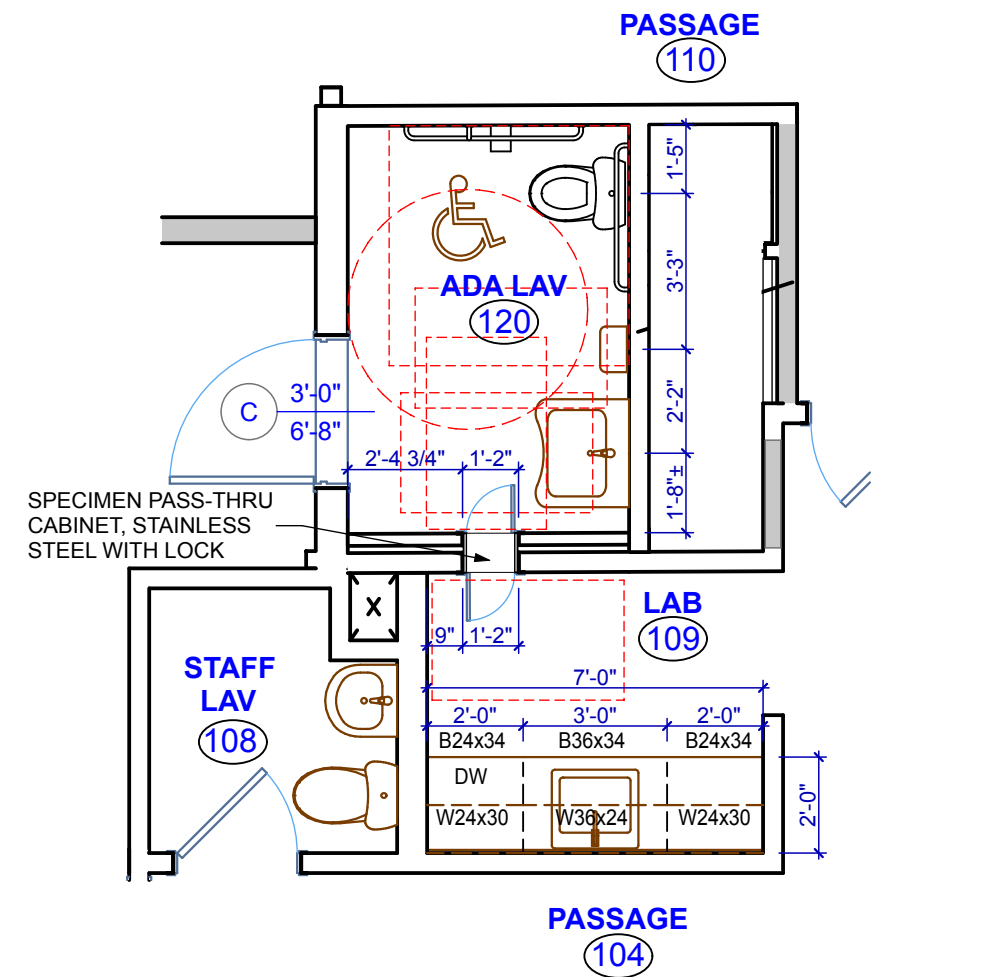


C4 A-113 PARTIAL ENLARGED PLAN SCALE: 1/4" = 1'-0"

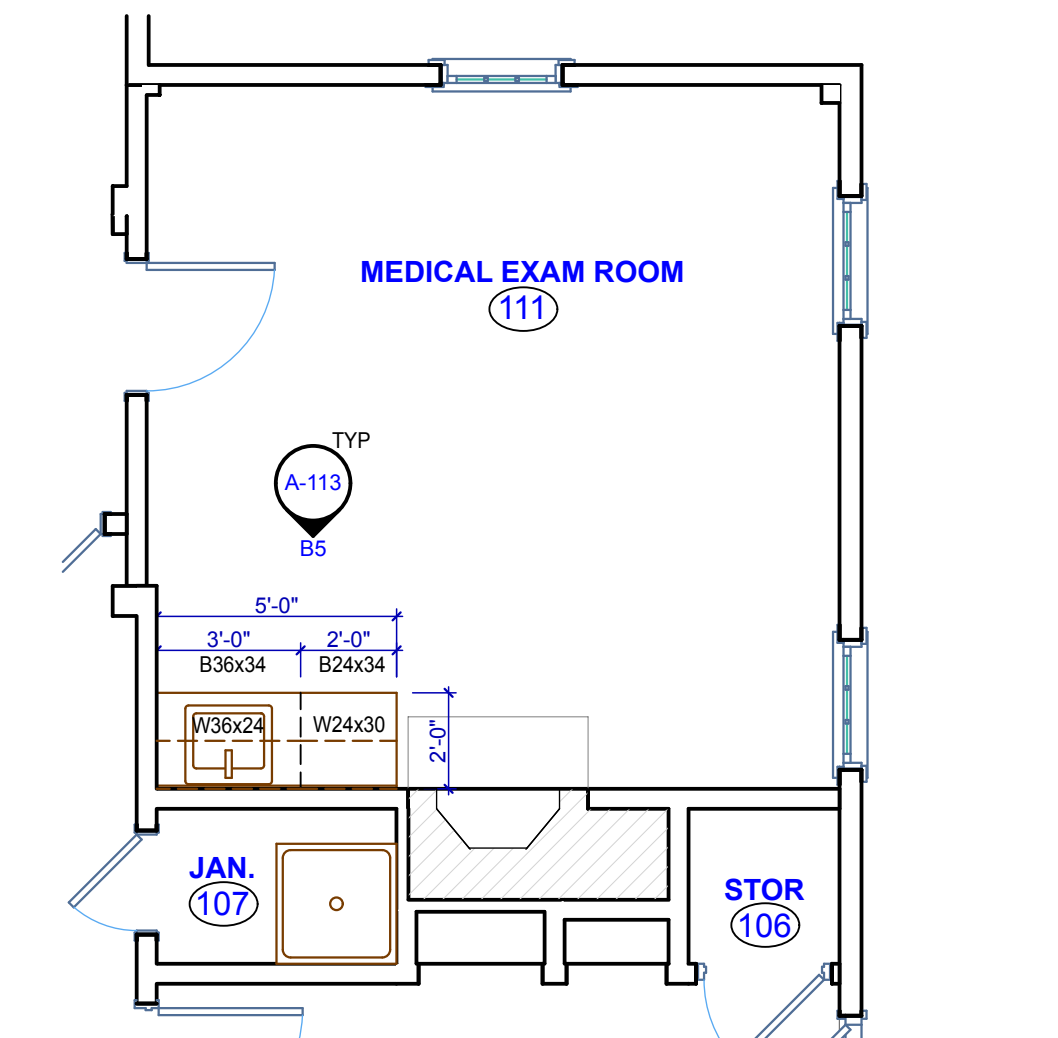


C5 A-113 PARTIAL ENLARGED PLAN SCALE: 1/4" = 1'-0"

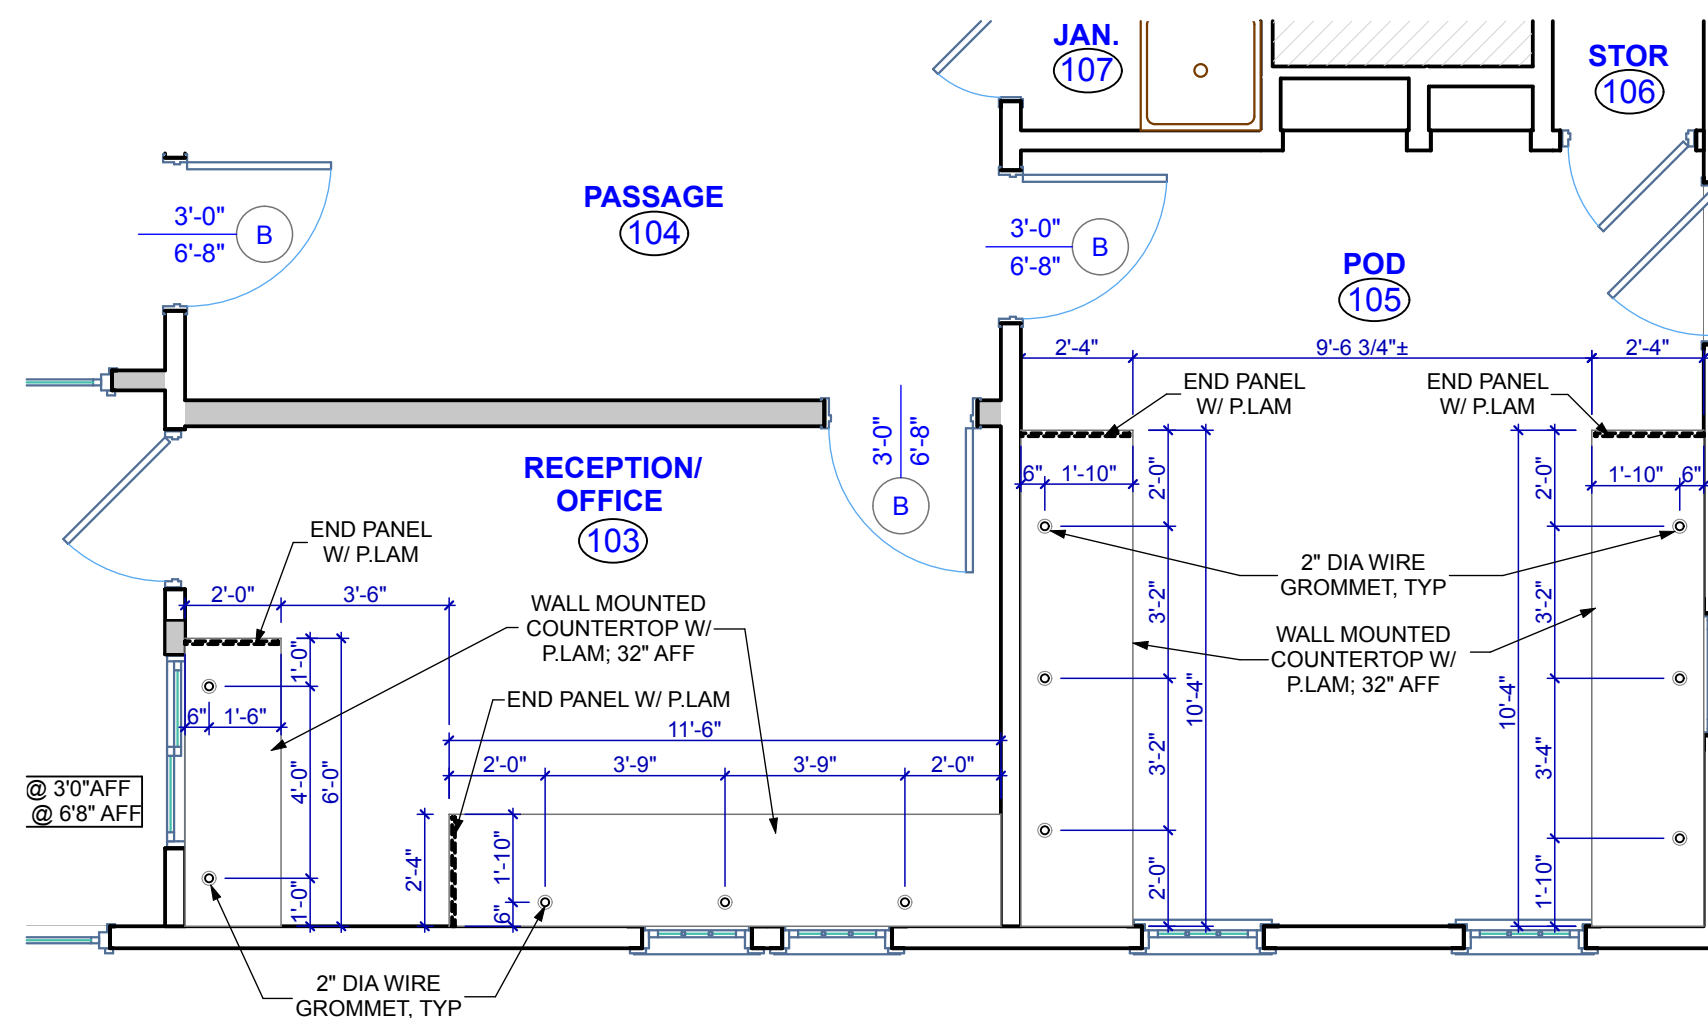

A3 A-113 PARTIAL ENLARGED PLAN SCALE: 1/4" = 1'-0"

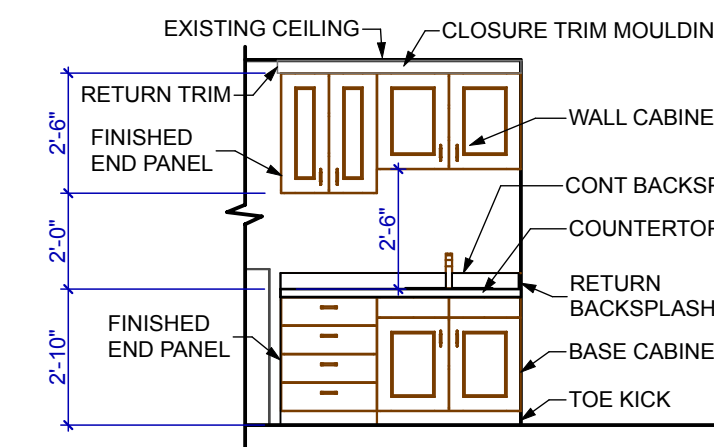

B5 A-113 TYP MILLWORK ELEVATION SCALE: 1/4" = 1'-0"

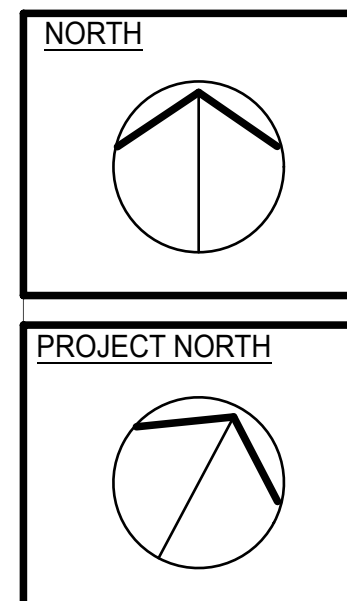

EBCAP - SWEETLAND HOUSE
610 Waterman Street
East Providence, RI 02914

REVISIONS:

ENLARGED PLANS
AND TYP WALL
TPYES

DATE: 10-06-21

NCA JOB NO.: 21111

DRAWING NO.:

A-113